


RIEGEL HOUSE

FISHERS ISLAND, NY

WEST WING - REVISION SET : 14 DECEMBER 2015

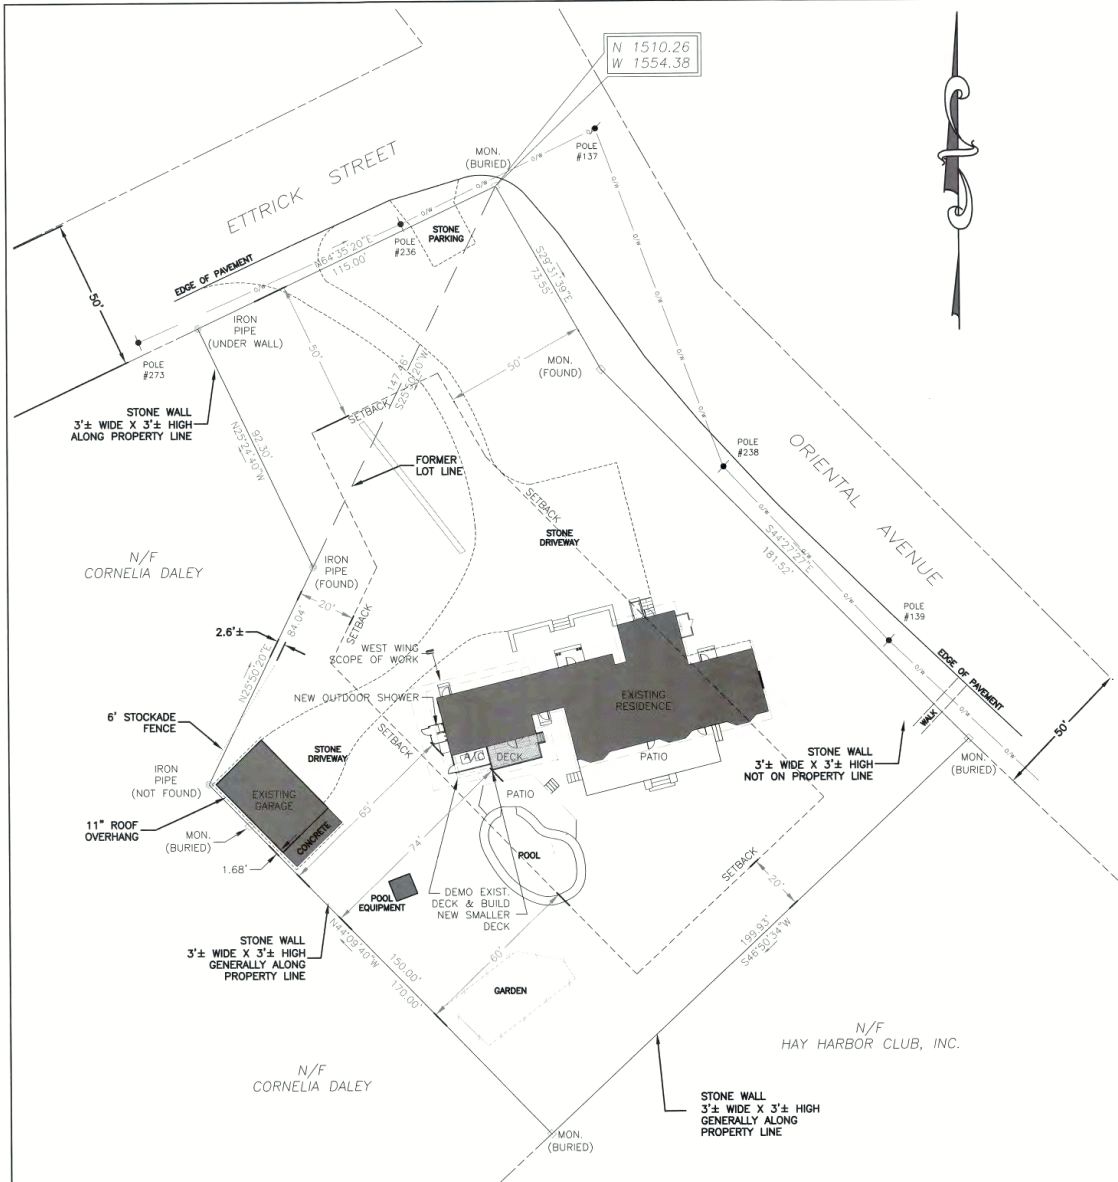

NOTES:
1.) BASED ON SURVEY BY CME ASSOCIATES.

TABLE OF CONTENTS

	PERMIT 08.28.15	PRICING 09.01.15	CONST. 12.03.15	CONST. 12.14.15
A1.0 TITLE PAGE/SITE PLAN SURVEYOR & CIVIL ENGINEER DWGS:	0	0	●	●
A2.0 PLANS: FOUNDATION	●			
A2.1 PLANS: FIRST FLOOR	0	0	●	●
A2.2 PLANS: SECOND FLOOR	0	0	●	●
A2.3 PLANS: ROOF	0	0	●	●
A3.1 EXTERIOR ELEVATIONS	0	0	●	●
A3.2 EXTERIOR ELEVATIONS	0	0	●	●
A4.0 BUILDING SECTIONS	0	0	●	●
A4.1 BUILDING SECTIONS	0	0		X
A5.0 WINDOW & DOOR SCHEDULE	0	0	●	●
A7.0 INTERIOR ELEVATIONS	0	0	●	●
A7.1 INTERIOR ELEVATIONS	0	0	●	●
STRUCTURAL DRAWINGS: GNCB			11	10 15
S1.0 FRAMING: NOTES & DETAILS	0	0	●	
S1.1 FND. & 1ST FL. FRAMING PLANS	0	0	0	X
S1.2 2ND FL. FRAMING PLAN & SECTION	0	0	0	X
S1.3 ATTIC & ROOF FRAMING PLANS	0	0	●	
S2.1 FRAMING DETAILS	0	0	●	
ELECTRICAL PLANS				
E2.1 ELECTRICAL PLANS: FIRST FLOOR	0	0	●	●
E2.2 ELECTRICAL PLANS: SECOND FLOOR	0	0	●	●
● DENOTES NEW DRAWINGS RESSUED UNDER CURRENT SET				
X DENOTES DRAWINGS REMOVED FROM CURRENT SET				

AR&T ARCHITECTS


262 Washington Street 2nd Floor Boston, MA 02108
617-451-5740 ARTArchitects.com

RIEGEL HOUSE - WEST WING
FISHERS ISLAND, NY

TITLE	DATE	ISSUE	DRAWN	CHECKED
SITE PLAN & DRAWING LIST	08.31.15	PERMIT	EJR	.DA
	09.01.15	PRICING	EJR	.DA
	12.03.15	CONSTRUCTION	EJR	.DA
	12.14.15	REVISION	EJR	.DA

JOB NUMBER	SCALE
1420	1"=20'

A1.0

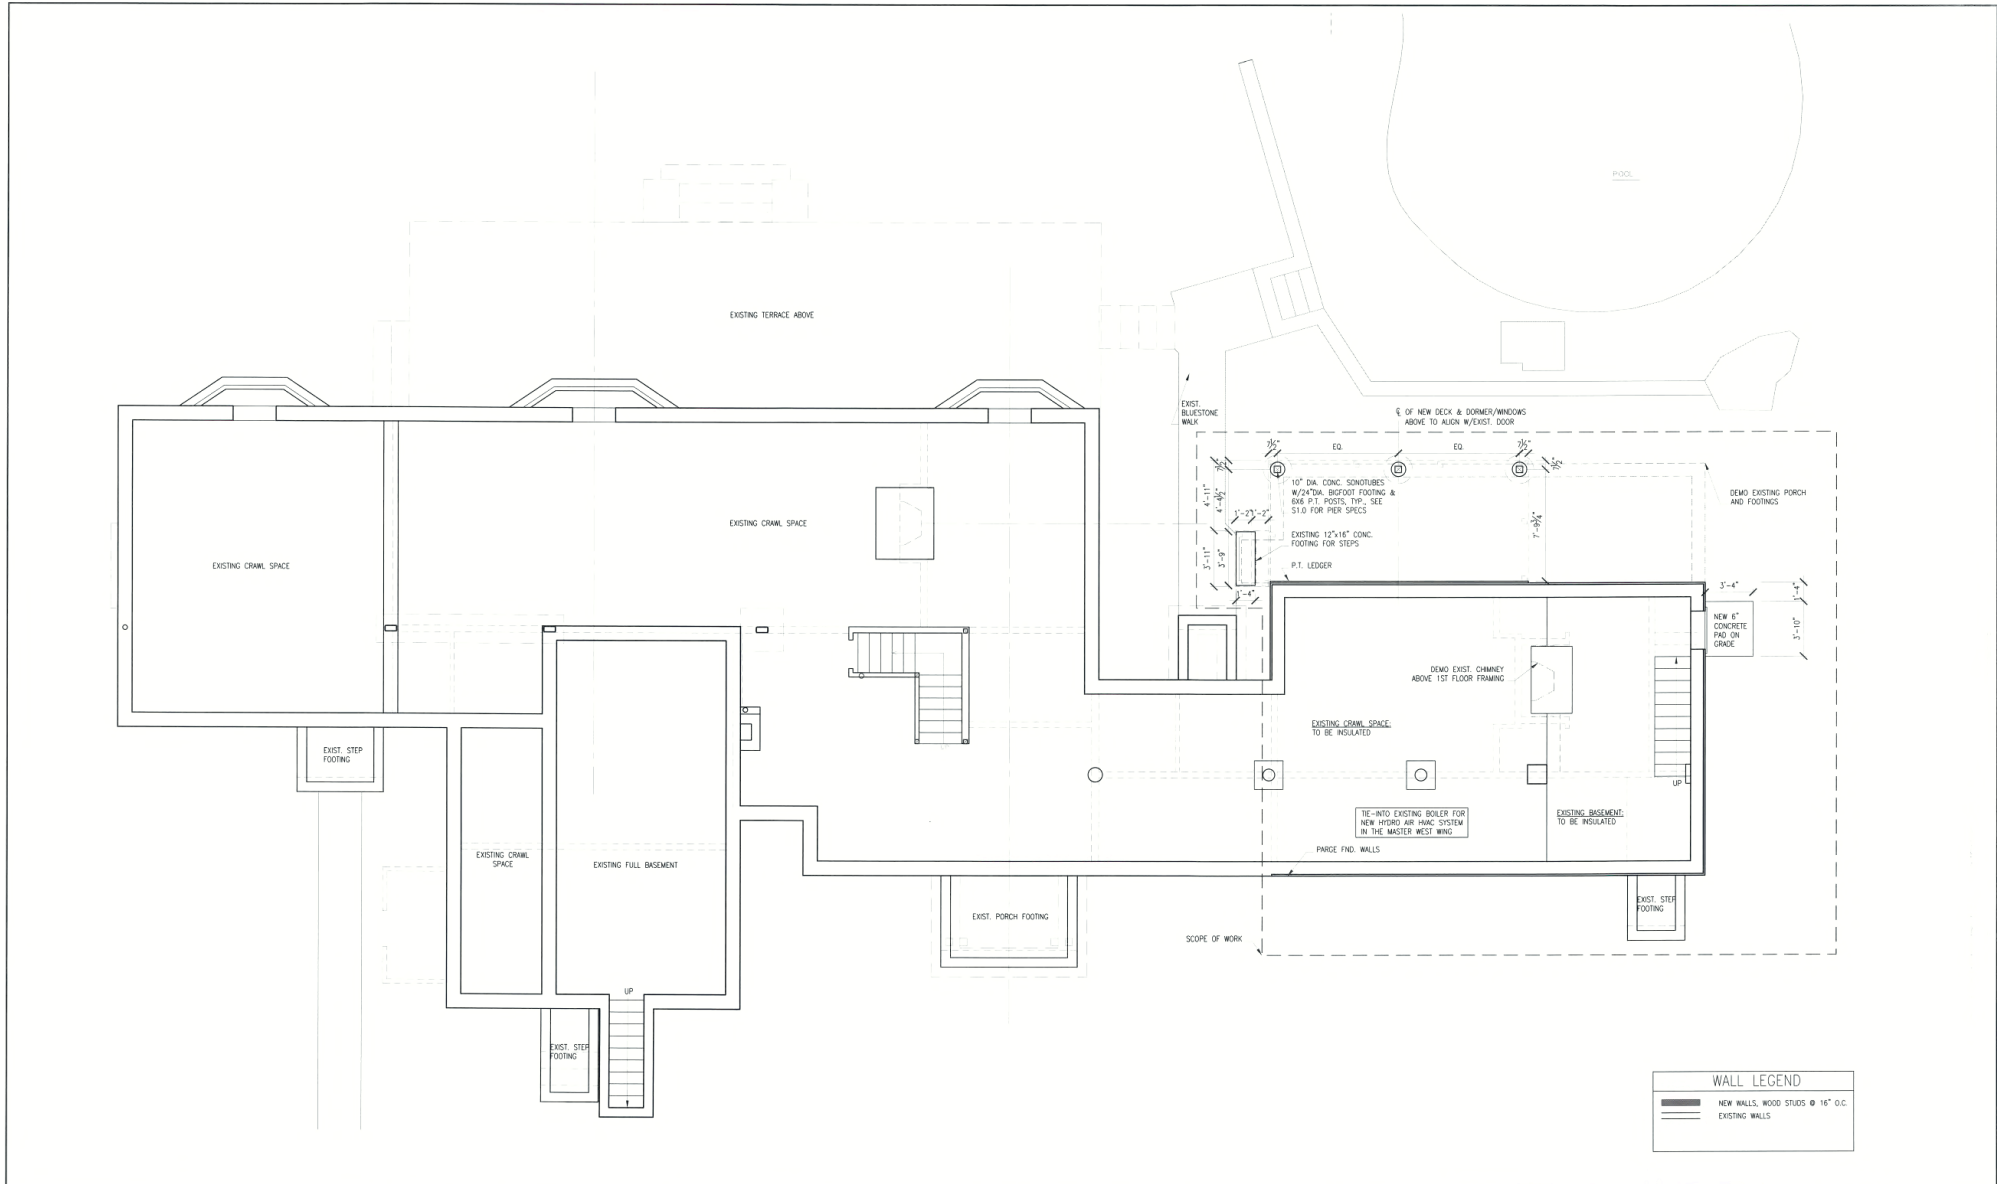

WALL LEGEND	
	NEW WALLS, WOOD STUDS @ 16" O.C.
	EXISTING WALLS


AR&T ARCHITECTS
 262 Washington Street 2nd Floor Boston, MA 02108
 617-451-5740 ARTArchitects.com

RIEDEL HOUSE - WEST WING
 FISHERS ISLAND, NY



TITLE	DATE	ISSUE	DRAWN	CHECKED
BASEMENT FLOOR PLAN	08.25.15	PERMIT	EJR	JBA
	08.28.15	PERMIT	EJR	JBA
	12.14.15	REVISION	EJR	JBA
JOB NUMBER	SCALE			
1420	1/4"=1'-0"			

A2.0

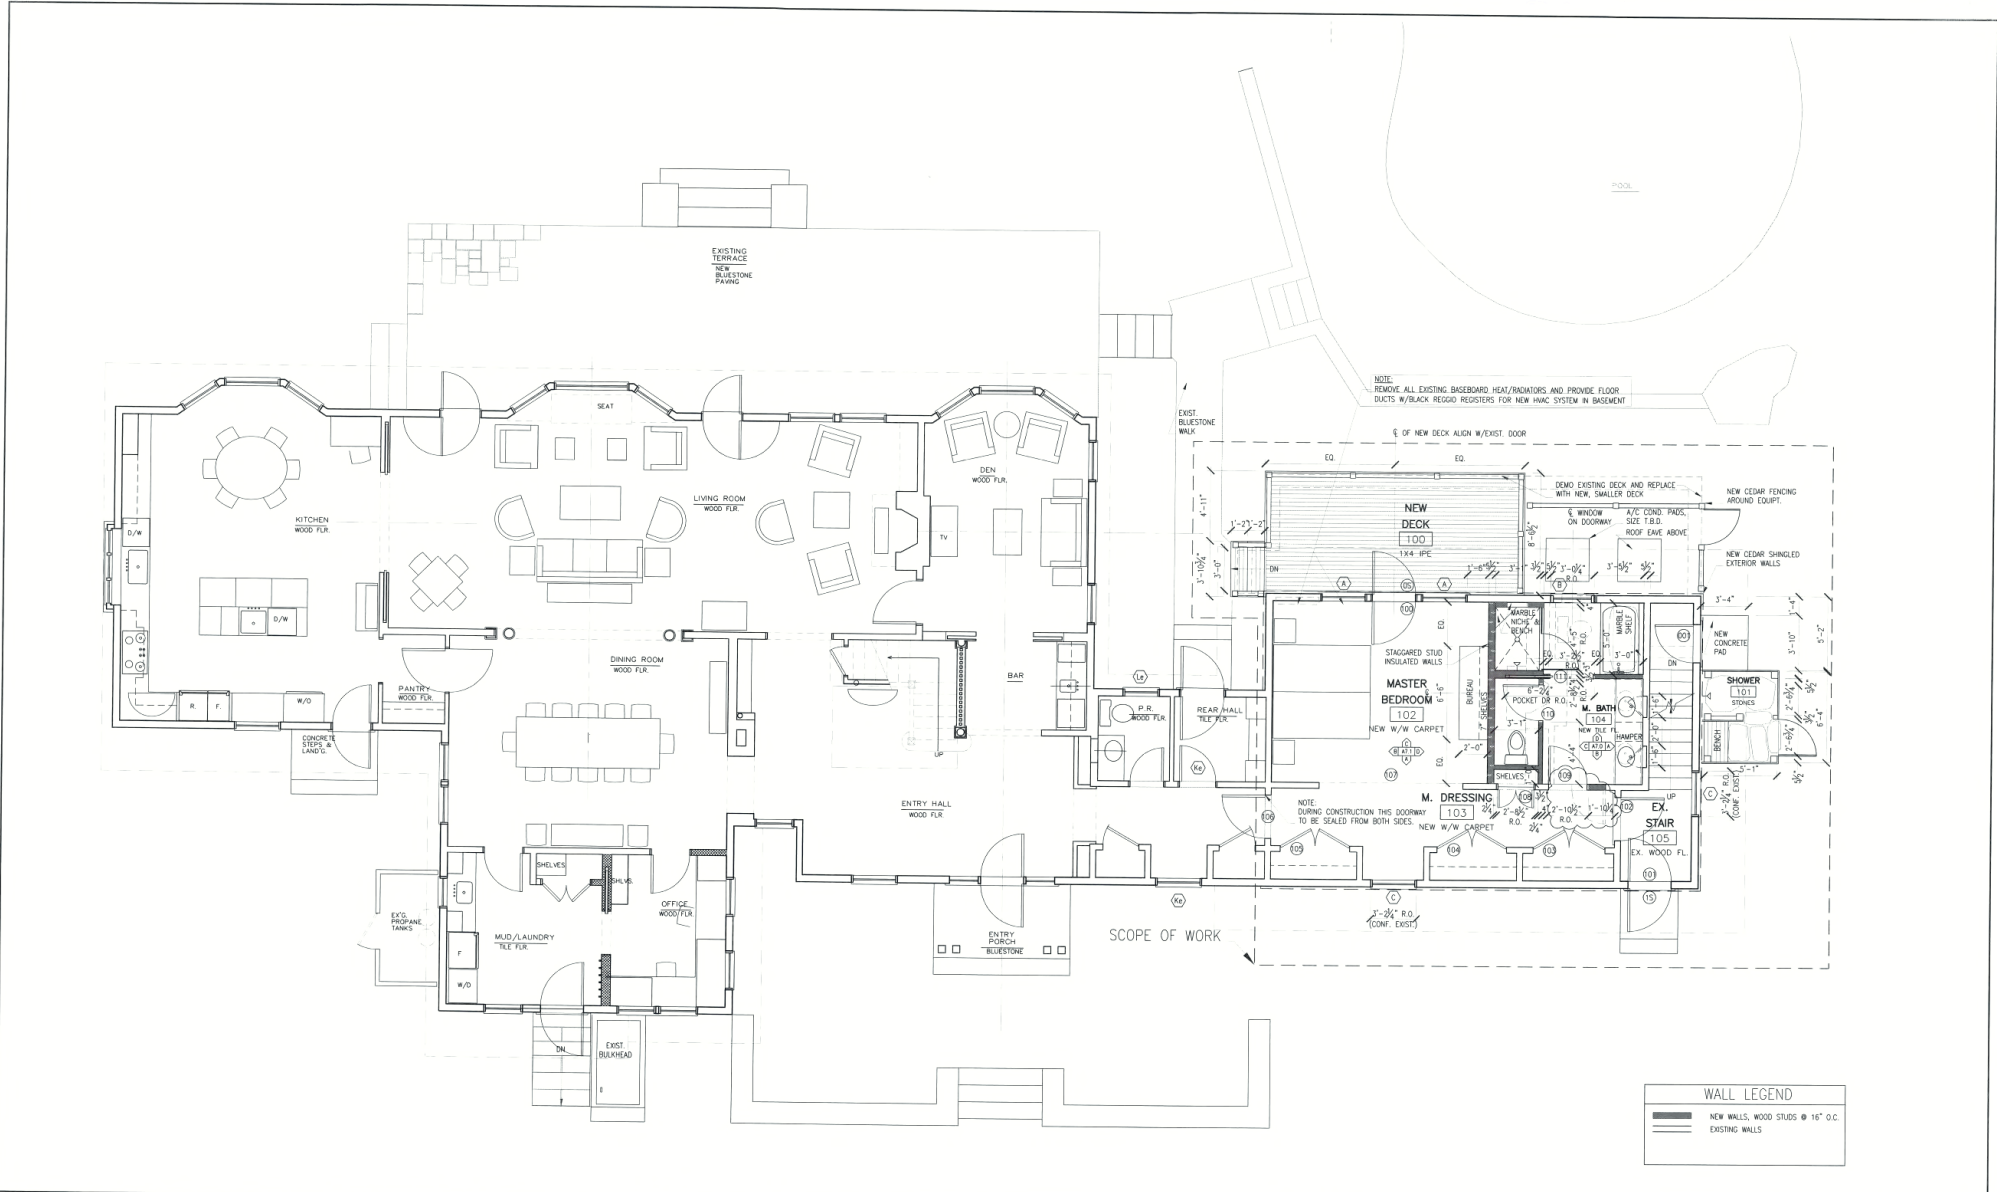


AR&T ARCHITECTS
262 Washington Street 2nd Floor Boston, MA 02108
617-451-5740 ARTarchitects.com

RIEGEL HOUSE - WEST WING
FISHERS ISLAND, NY



TITLE	DATE	ISSUE	DRAWN	CHECKED
FIRST FLOOR PLAN	07.28.15	REVIEW	EJR	JDA
	08.25.15	PERMIT	EJR	JDA
	08.28.15	PERMIT	EJR	JDA
	09.01.15	PROVIDE	EJR	JDA
	09.03.15	CONSTRUCTION	EJR	JDA
	12.14.15	REVISION	EJR	JDA
JOB NUMBER	SCALE			
1420	1/4" = 1'-0"			

A2.1

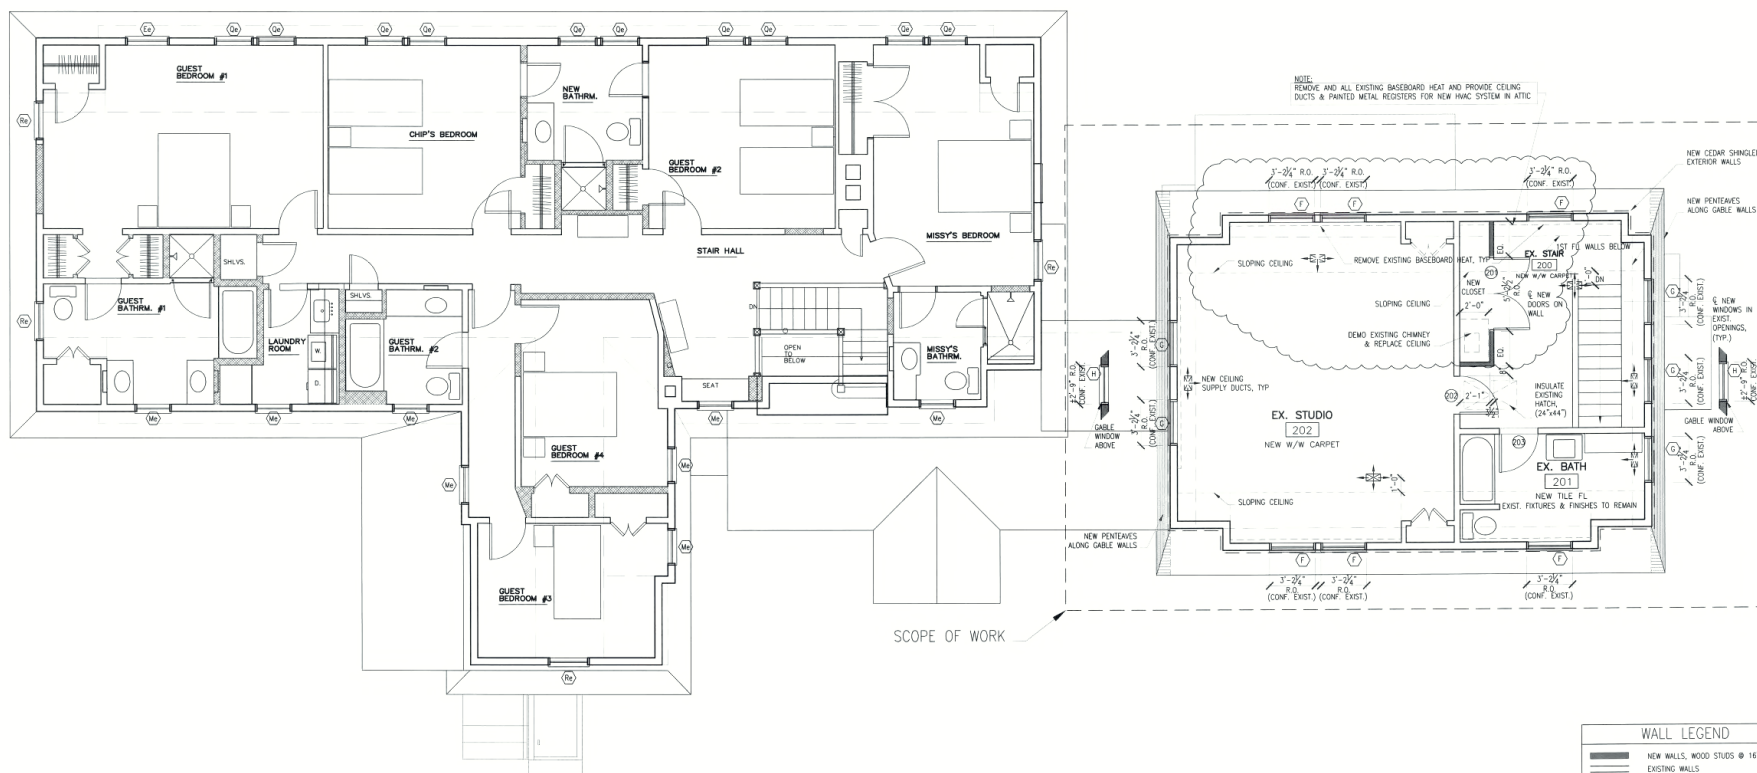

AR&T ARCHITECTS
 262 Washington Street 2nd Floor Boston, MA 02108
 617-451-5740 ARTArchitects.com

RIEDEL HOUSE - WEST WING
 FISHERS ISLAND, NY



TITLE		DATE	ISSUE	DRAWN	CHECKED
SECOND FLOOR PLAN		07.28.15	REVIEW	EAR	JDA
		08.25.15	PERMIT	EAR	JDA
		08.28.15	PERMIT	EAR	JDA
		12.03.15	CONSTRUCTION	EAR	JDA
		12.14.15	REVISION	EAR	JDA
JOB NUMBER	SCALE				
1420	1/4"=1'-0"				

A2.2